



FRONT ENTRANCE TO SCHOOL








WEST ELEVATION TO SCHOOL


DATUM 0.00m

DATUM 0.00m




SCALE BAR


 <b>Offington Land Surveys</b> 29 Offington Drive Worthing West Sussex BN14 9PW Tel/fax 01903 267883 Chartered Surveyors			Job <b>XXXX</b> Drawing No. <b>XXXXXXXX Elevations</b>	
Plot Scale: 1:100	Sheet Size: A2 Landscape	Version: 1.0	Date: <i>1/1/17</i>	Copyright © 2017
<b>STANDARD REFERENCE</b> Datum Used <u>Newlyn</u> Local survey translated to Newlyn and OSGB36 by direct acquisition of control stations using RTK GPS to accuracy +/- 50 mm RMS.			<b>ABBREVIATIONS</b>	
Survey Station Shown Thus: Foul Water Drainage  Storm Water Drainage  Water Mains  Gas Mains  Electricity Cable  British Telecom Cable 			IC Inspection Chamber IL Invert Level LP Lamp Post MM Manhole RG Road Gully RS Road Sign RWP Rain Water Pipe SG Stop Cock SV Stop Valve SVP Soil & Vent Pipe TP Telegraph Pole VP Vent Pipe WM Water Meter WO Water Wash Out	
True north direction shown is indicative only.  The details shown hereon relating to all underground services are as obtained by normal above-ground survey observation and methods.  Although all reasonable efforts have been made no guarantee can be given for the completeness or accuracy of this information.			<b>FENCES</b> FCB Close Boarded FP Panel FCP Chestnut Paling FPR Post & Rail FPX Picket FPW Post & Wire FPM Metal Palisade FTR Trellis	

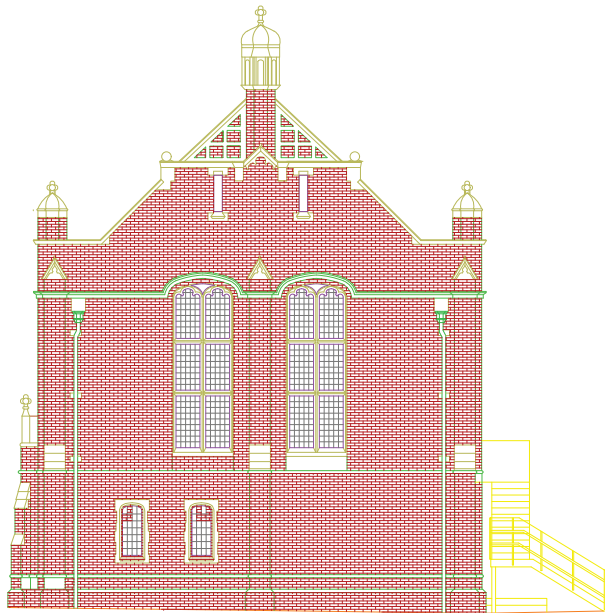

SOUTH ELEVATION TO SCHOOL

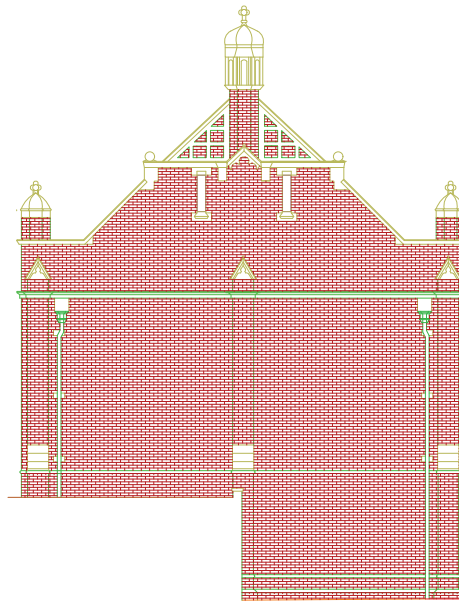

NORTH ELEVATION TO SCHOOL

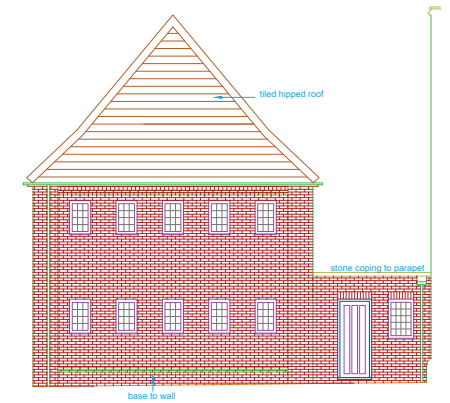








NORTH ELEVATION TO IZZARD ROOM

DATUM 0.00m

DATUM 0.00m



SCALE BAR

 <b>Offington Land Surveys</b> 29 Offington Drive Worthing West Sussex BN14 9PW Chartered Surveyors Tel/fax 01903 267883		Job <b>XXXX</b> Drawing No. <b>XXXXXXXX Elevations</b>	
Plot Scale: 1:100	Sheet Size: A2 Landscape	Version: 1.0	Date: <i>1/1/17</i>
<b>STANDARD REFERENCE</b> Datum Used <u>Newlyn</u> Local survey translated to Newlyn and OSGB36 by direct acquisition of control stations using RTK GPS to accuracy +/- 50 mm RMS.		<b>ABBREVIATIONS</b> BT British Telecom IC IC Inspection Chamber CATV Television Cable Pit IL Invert Level CB Concrete Bollard LP Lamp Post CE Cleaning Eye MM Manhole CL Cover Level RG Road Gully CM Cable Marker RS Road Sign CP Catch Pit RWP Rain Water Pipe ECP Electricity Cable Pit SQ Stop Cock EP Electricity Pole SV Stop Valve FA Fire Alarm SVP Soil & Vent Pipe FH Fire Hydrant TP Telegraph Pole FL Floor Level VP Vent Pipe G Gully WM Water Meter WO Water Wash Out	
<b>Survey Station Shown Thus:</b> Foul Water Drainage  Storm Water Drainage  Water Mains  Gas Mains  Electricity Cable  British Telecom Cable 		<b>FENCES</b> FCB Close Boarded FP Panel FCP Chestnut Paling FPR Post & Rail FPX Picket FPW Post & Wire FPM Metal Palisade FTR Trellis	
True north direction shown is indicative only.  The details shown hereon relating to all underground services are as obtained by normal above-ground survey observation and methods.  Although all reasonable efforts have been made no guarantee can be given for the completeness or accuracy of this information.			